



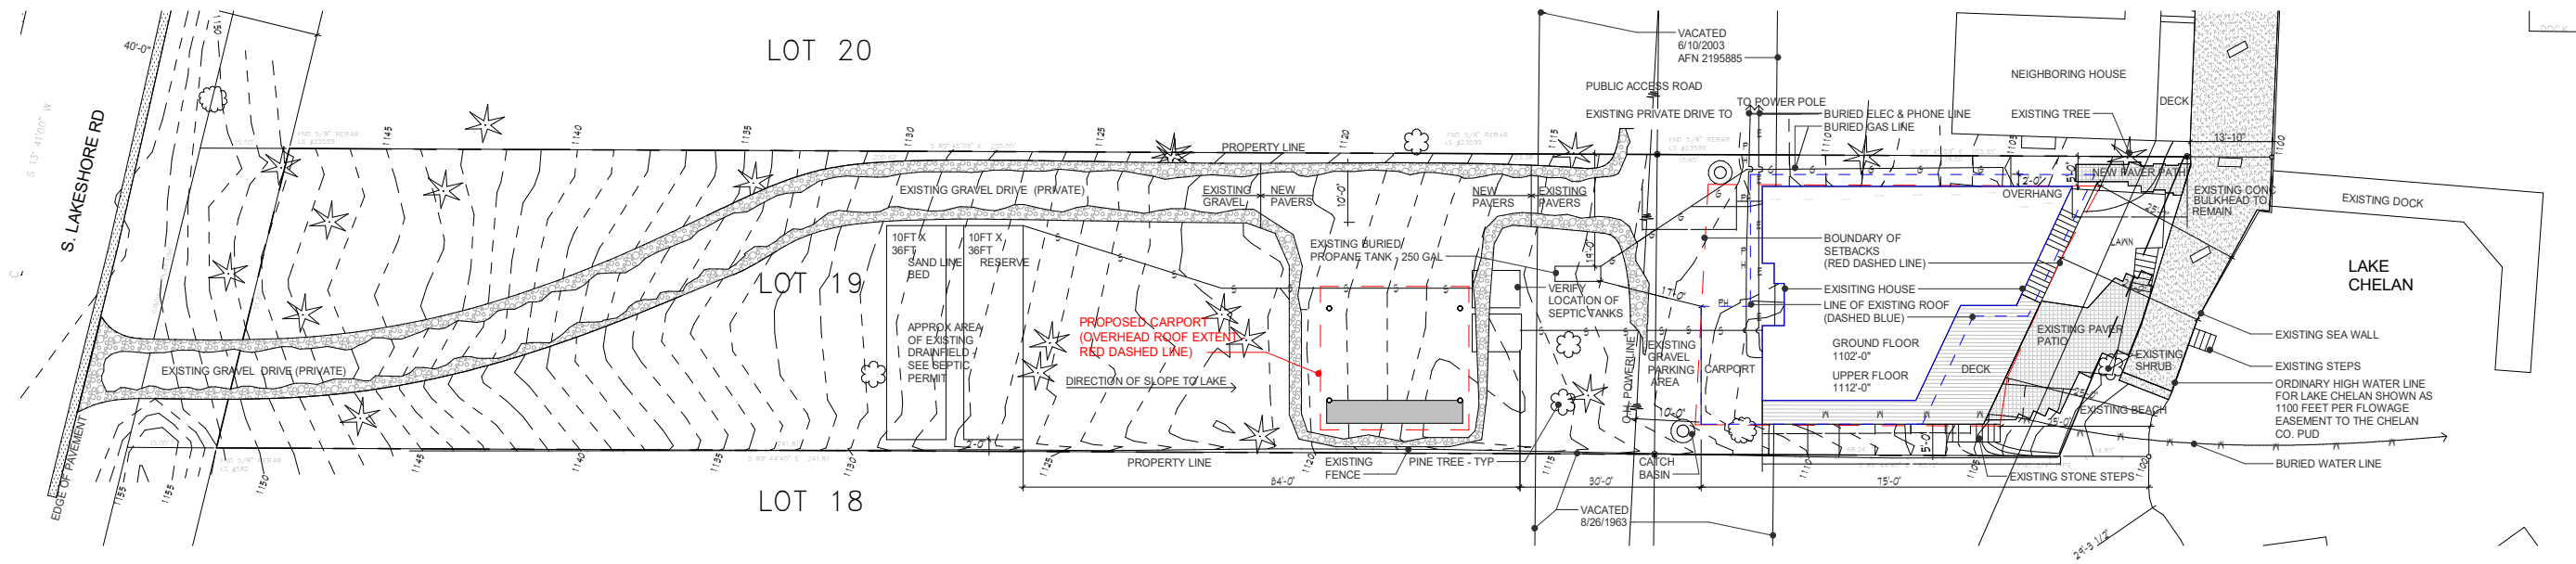


Site 1
SCALE: 1" = 30'-0"


CITY/COUNTY SEAL:	STRUC SEAL:	ARCH SEAL:	studio-skh Sean Haste 1221 E Pike St. Suite 300, Seattle, WA 98122 206.503.3619	Caroline's Carport 12430 S. Lakeshore Rd Chelan, WA 98816	ISSUE DATE: 02/23/22 <table><tr><th>No.</th><th>Description</th><th>Date</th></tr><tr><td>1</td><td>PROGRESS SET</td><td>03/01/23</td></tr><tr><td></td><td></td><td></td></tr><tr><td></td><td></td><td></td></tr></table> FOR REVIEW ONLY	No.	Description	Date	1	PROGRESS SET	03/01/23							Site Plan SCALE: 1" = 30'-0"	A2.0
No.	Description	Date																	
1	PROGRESS SET	03/01/23																	

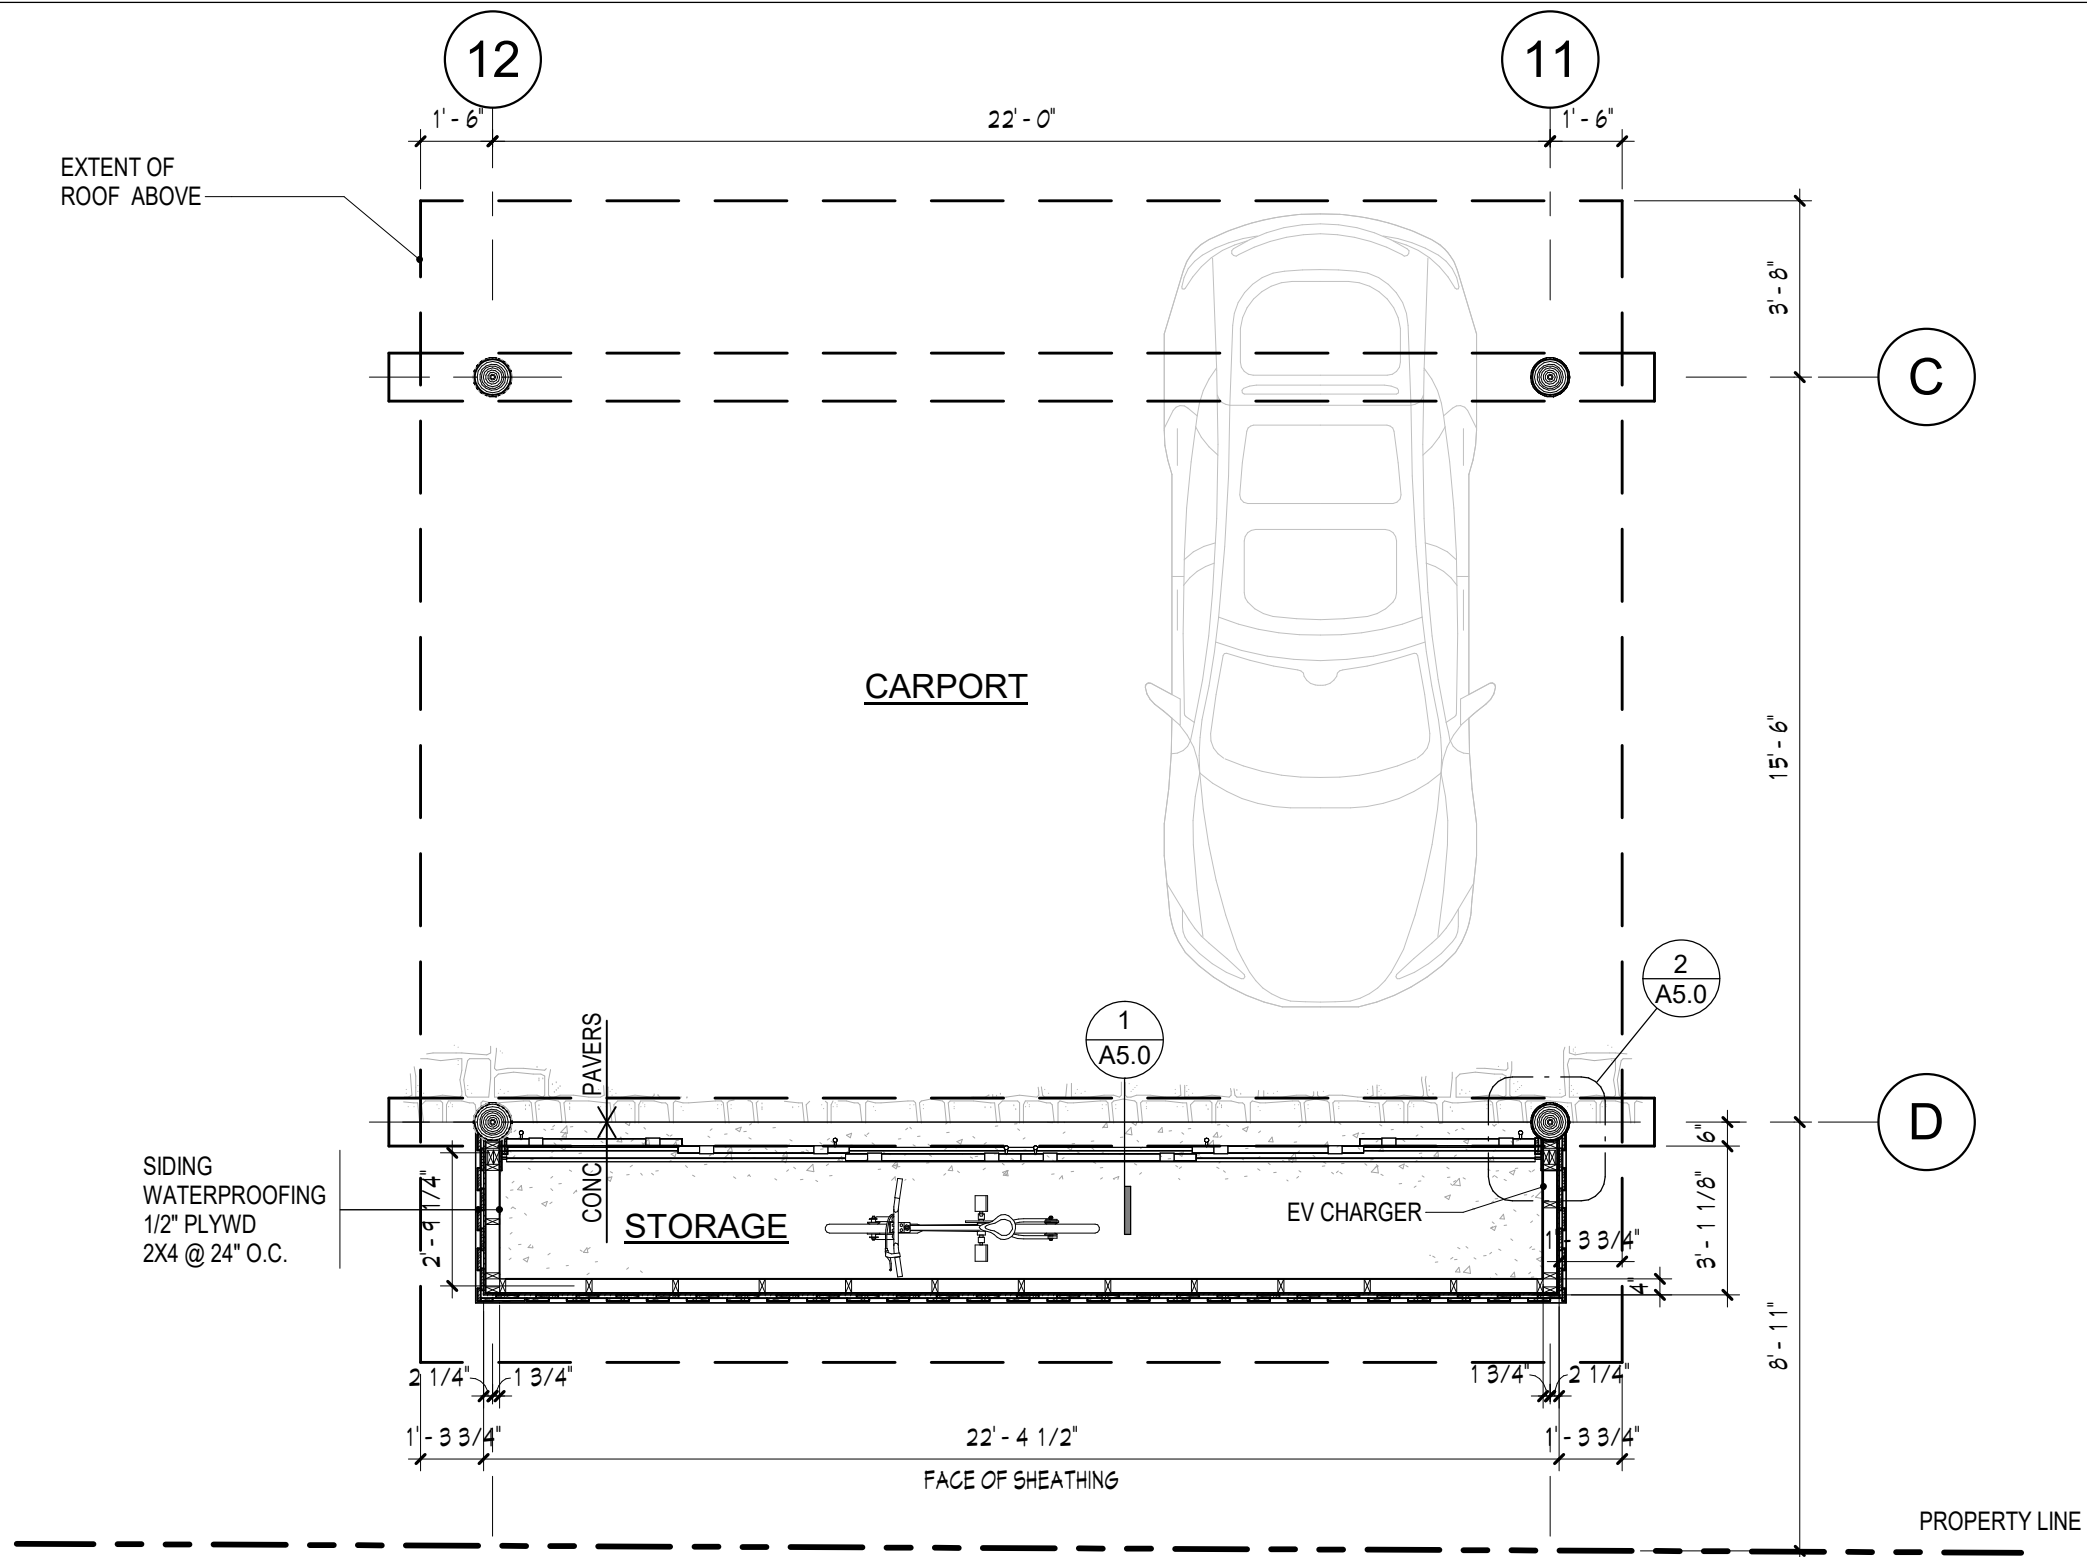




Floor Plan 1
SCALE: 1/4" = 1'-0"

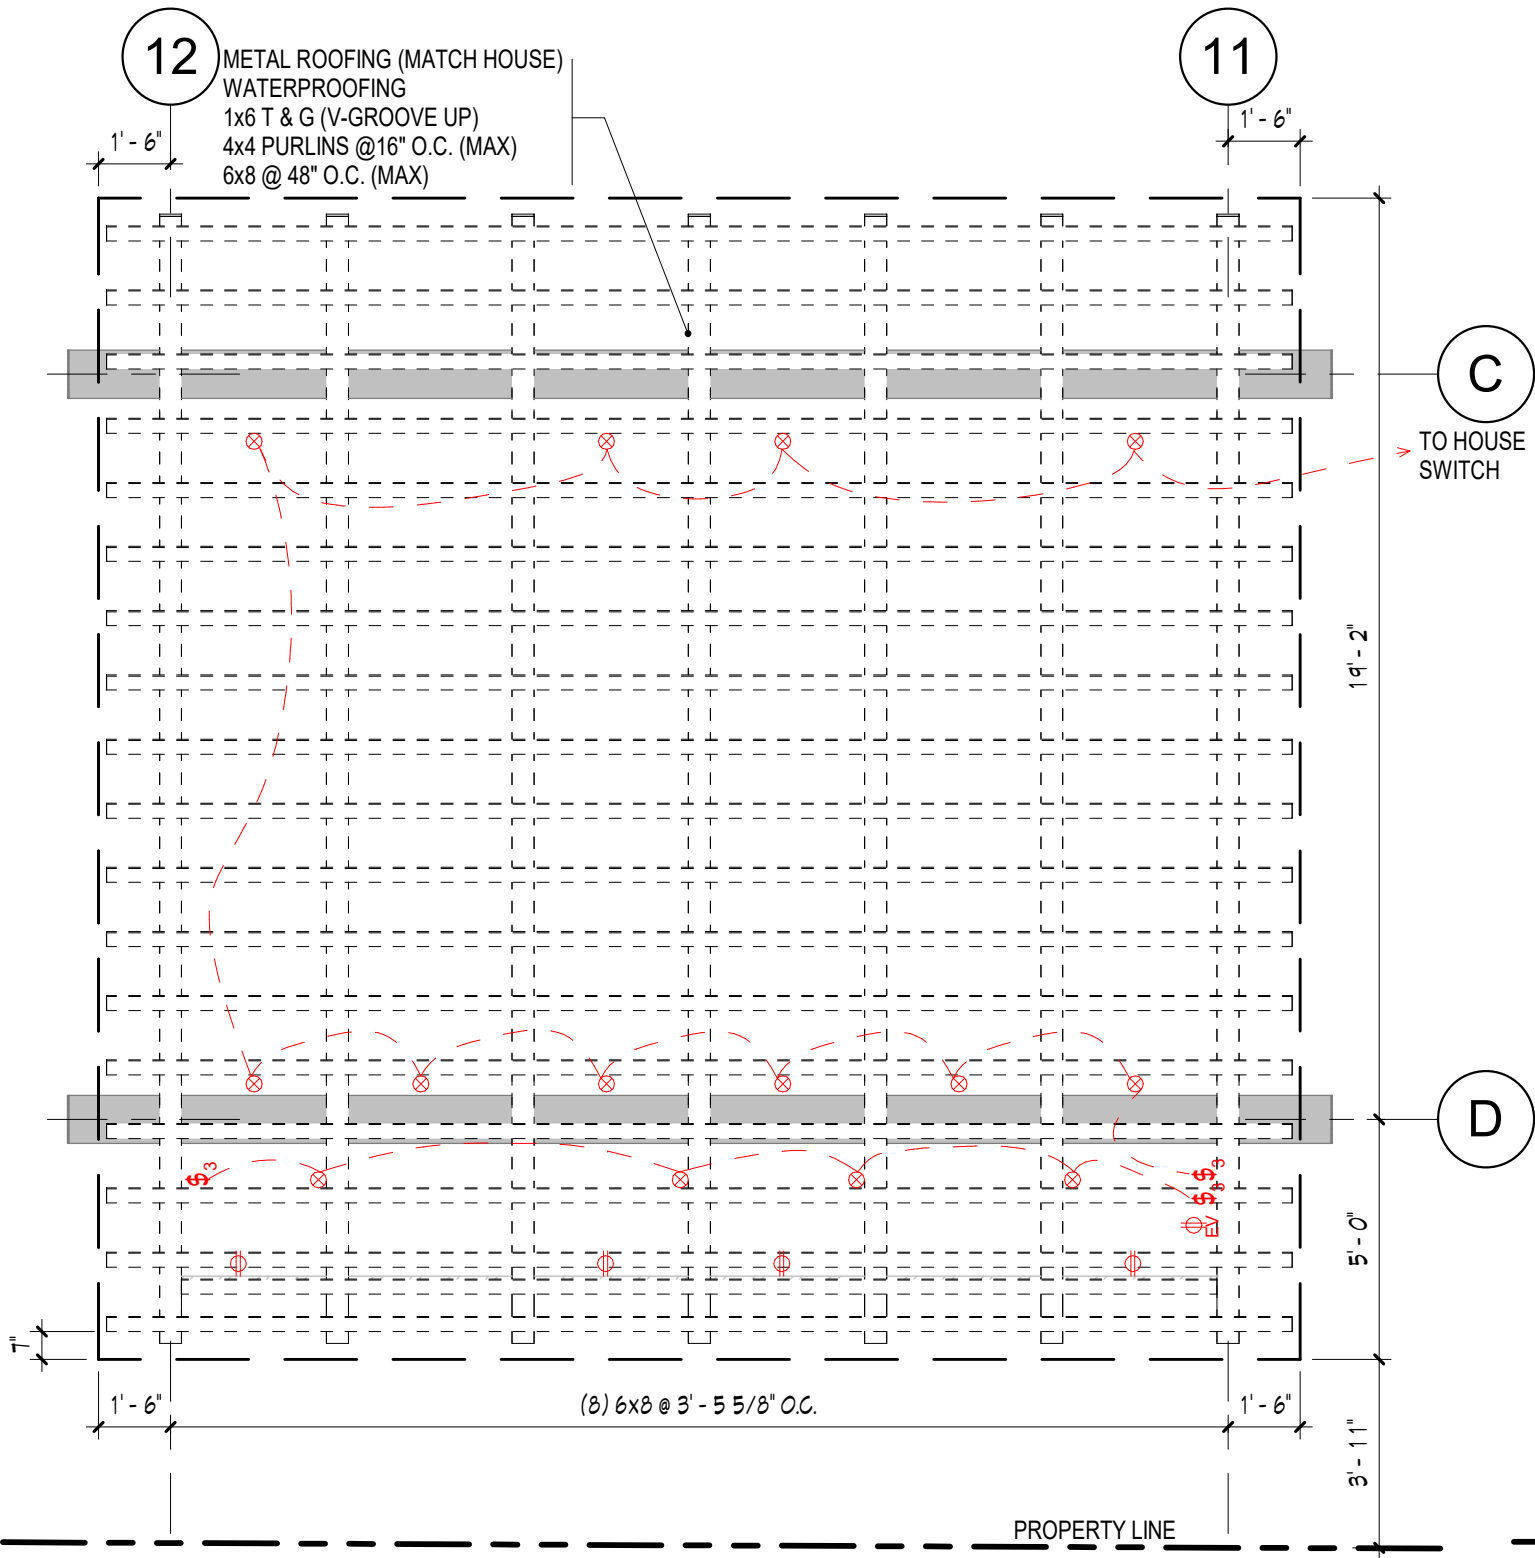

Roof Framing & Electrical Plan
SCALE: 1/4" = 1'-0"
2

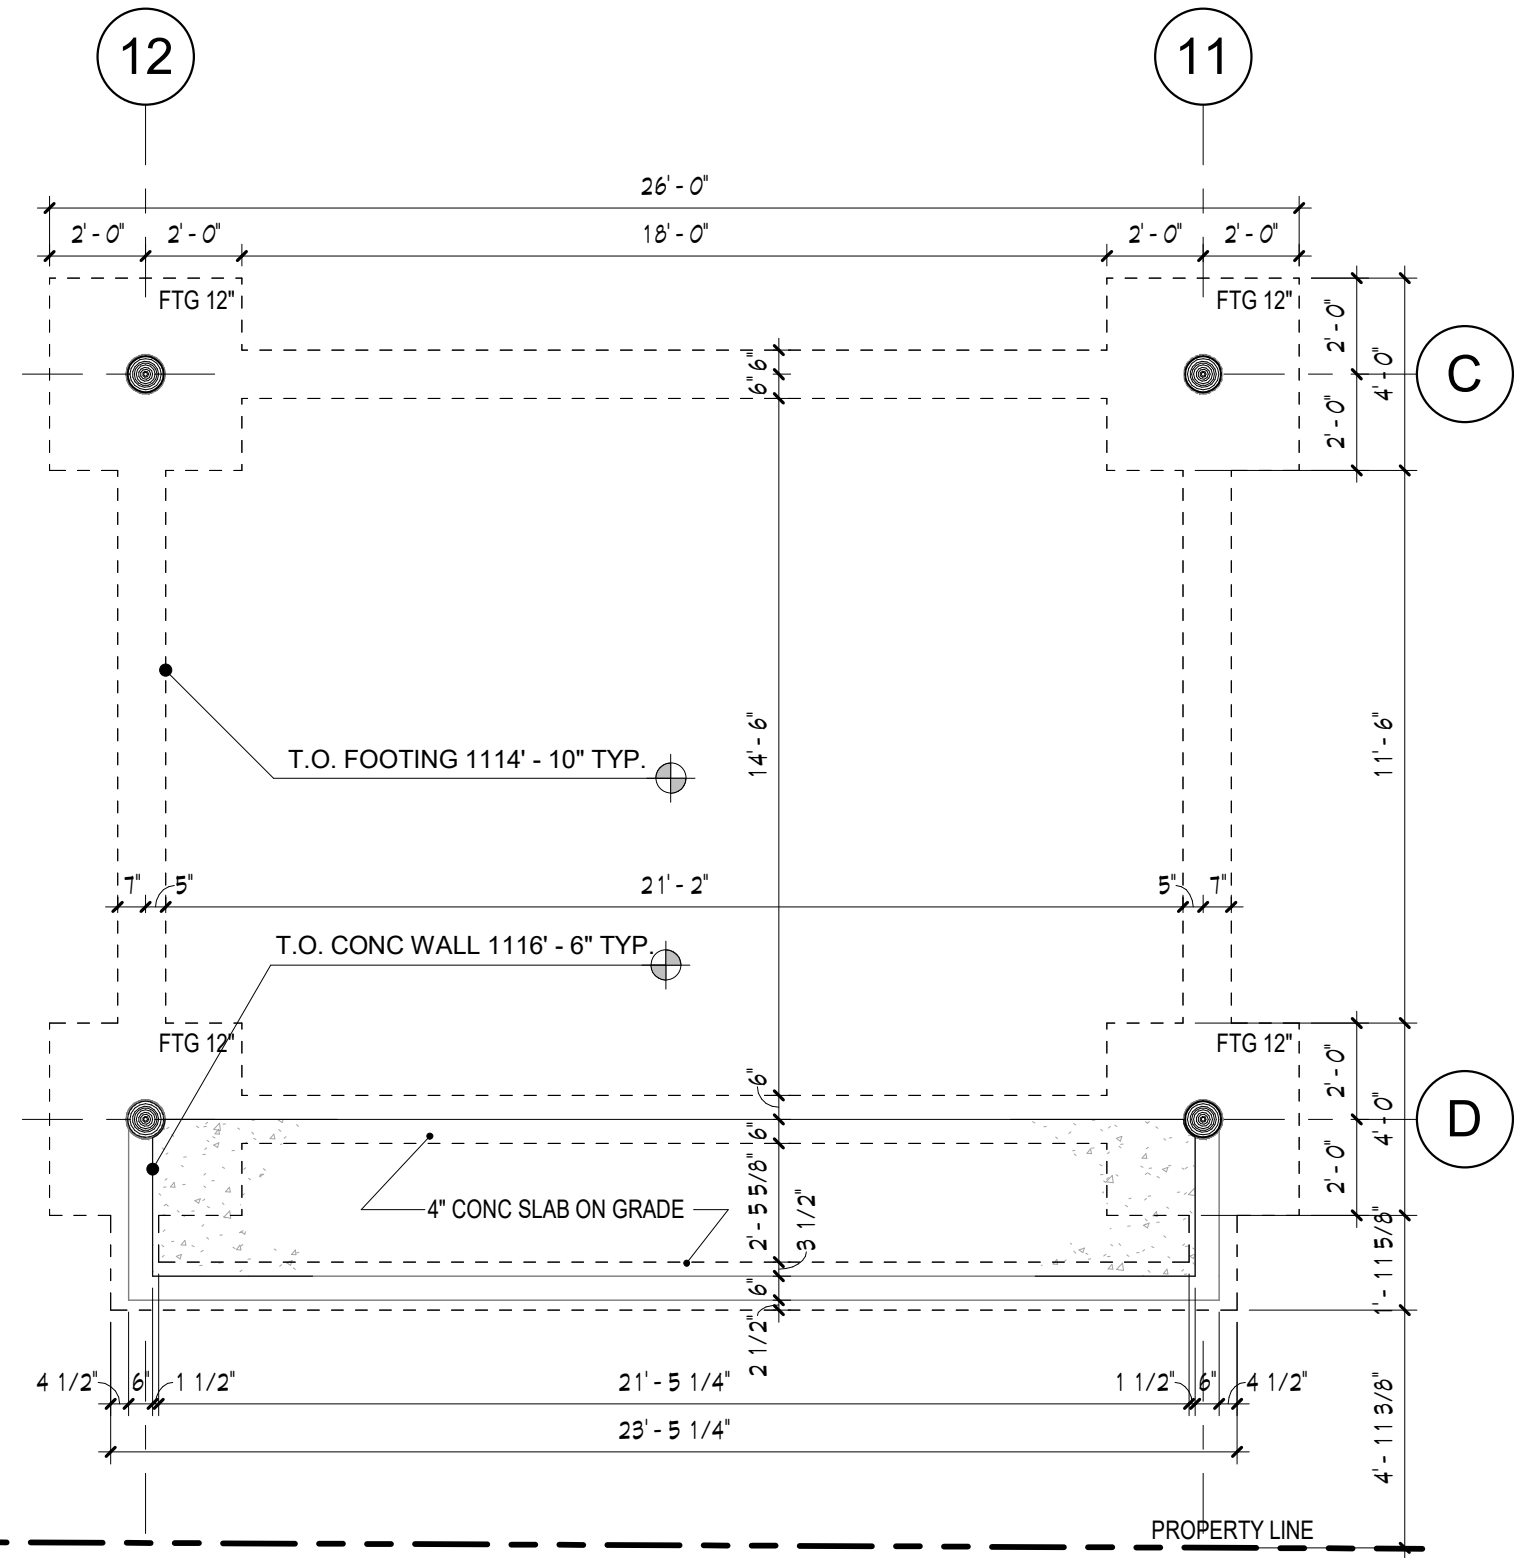


Foundation Plan
SCALE: 1/4" = 1'-0"
1

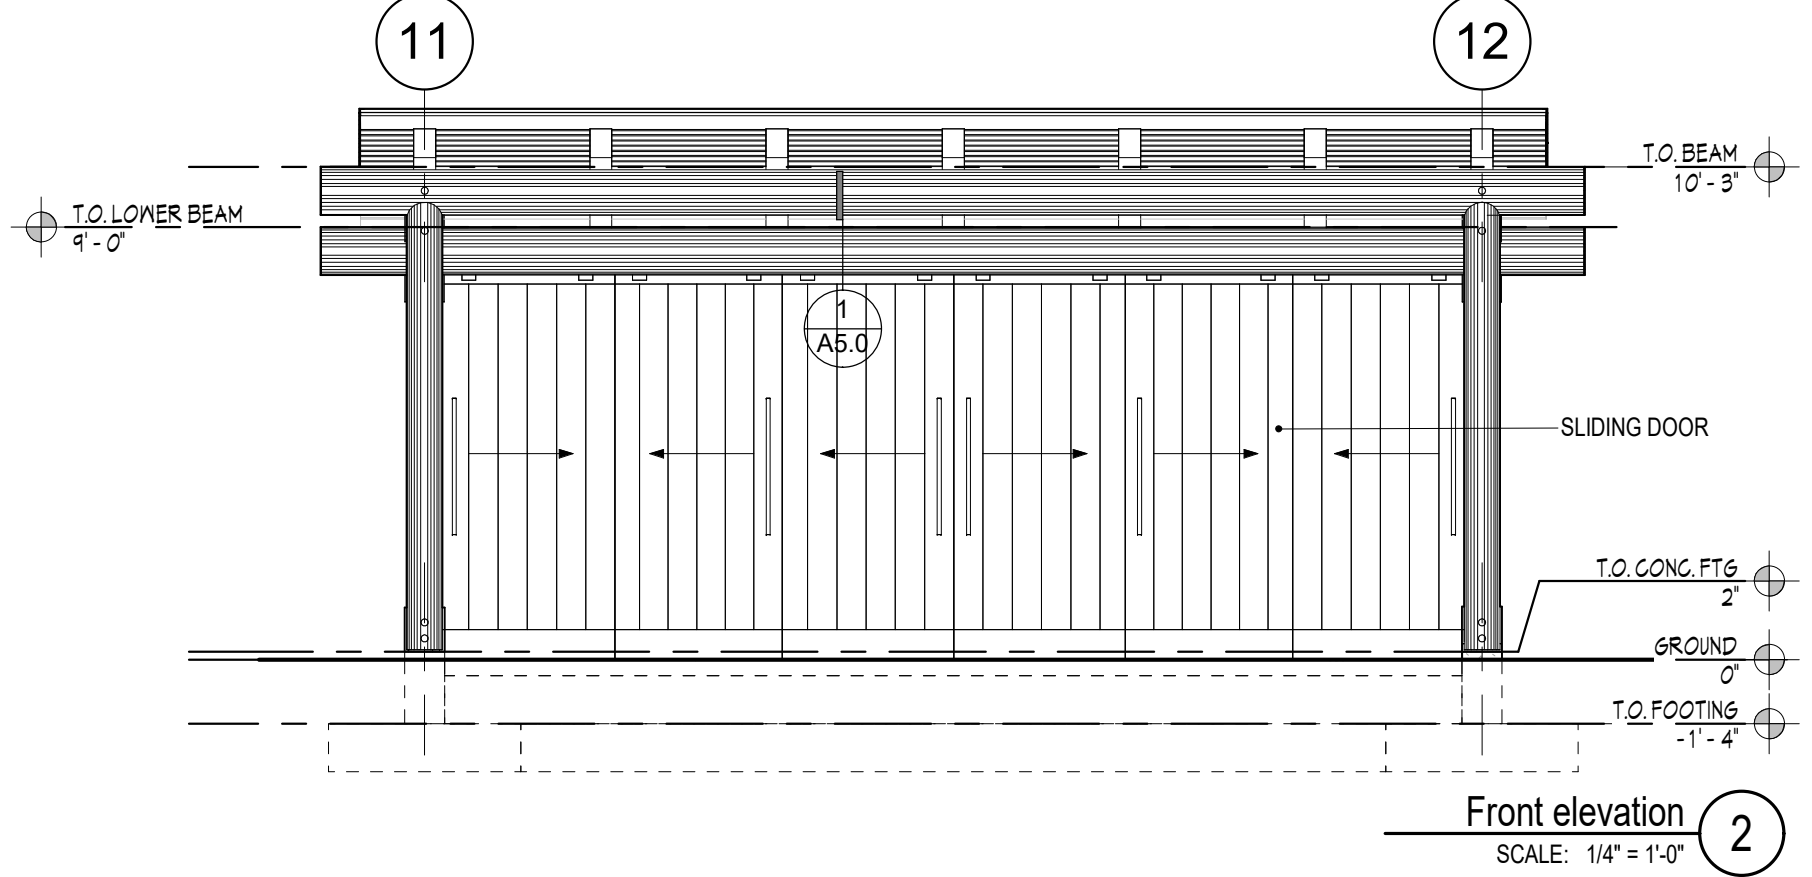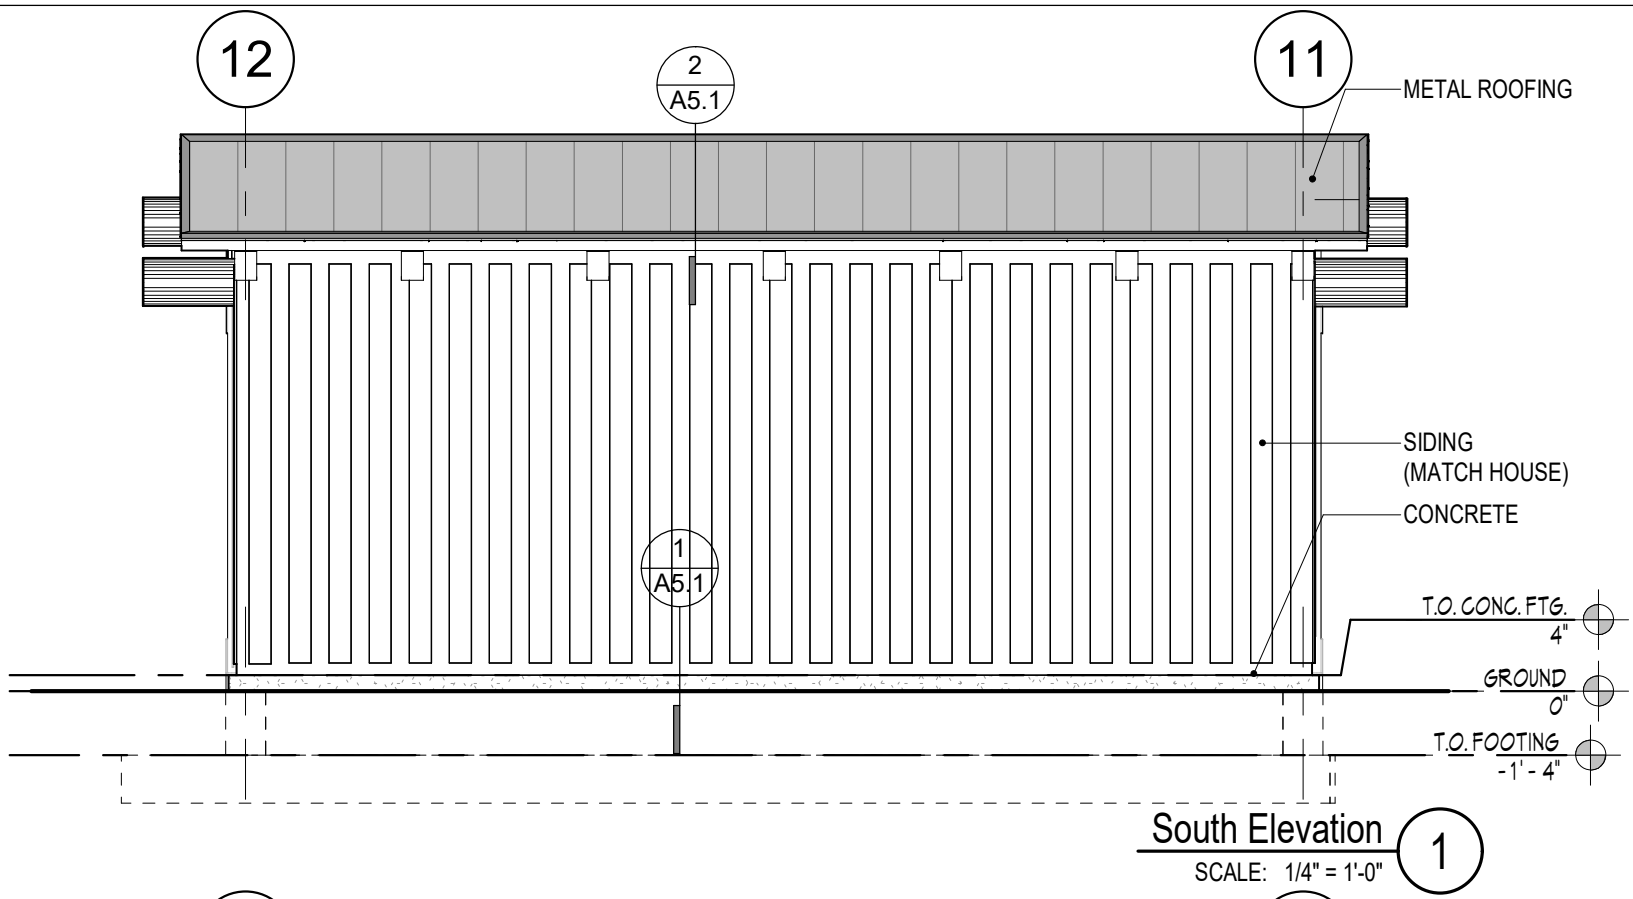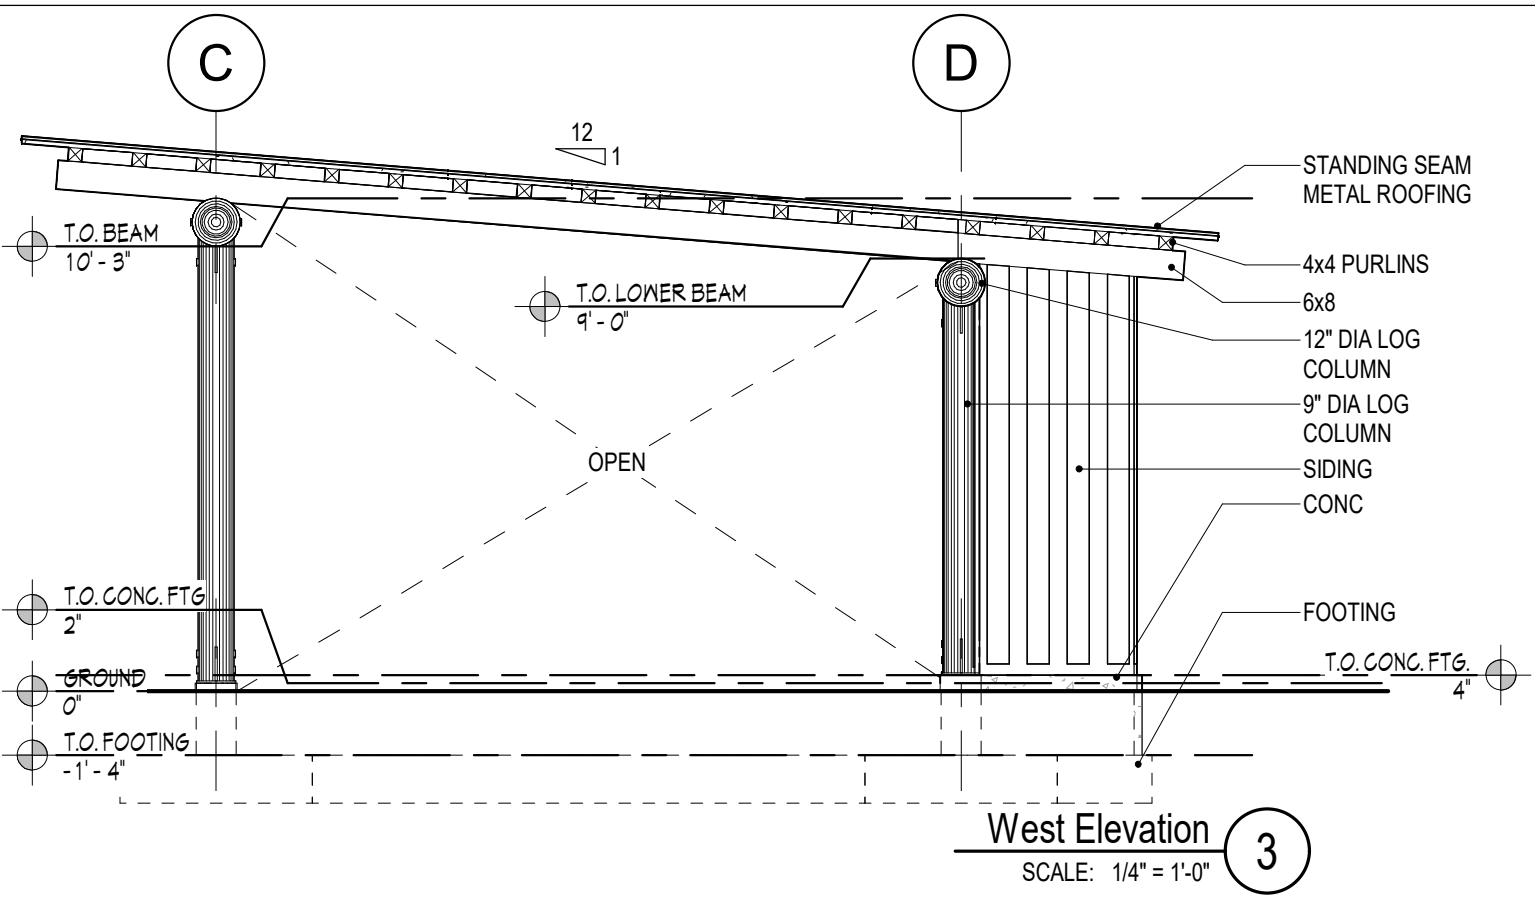


CITY/COUNTY SEAL:	STRUC SEAL:	ARCH SEAL:	studio-skh Sean Haste 1221 E Pike St. Suite 300, Seattle, WA 98122 206.503.3619	Caroline's Carport 12430 S. Lakeshore Rd Chelan, WA 98816	ISSUE DATE: 02/23/22 <table><tr><th>No.</th><th>Description</th><th>Date</th></tr><tr><td>1</td><td>PROGRESS SET</td><td>03/01/23</td></tr><tr><td></td><td></td><td></td></tr><tr><td></td><td></td><td></td></tr></table>	No.	Description	Date	1	PROGRESS SET	03/01/23							Elevations SCALE: 1/4" = 1'-0"	A3.0
No.	Description	Date																	
1	PROGRESS SET	03/01/23																	

9/12/2024 3:34:46 PM

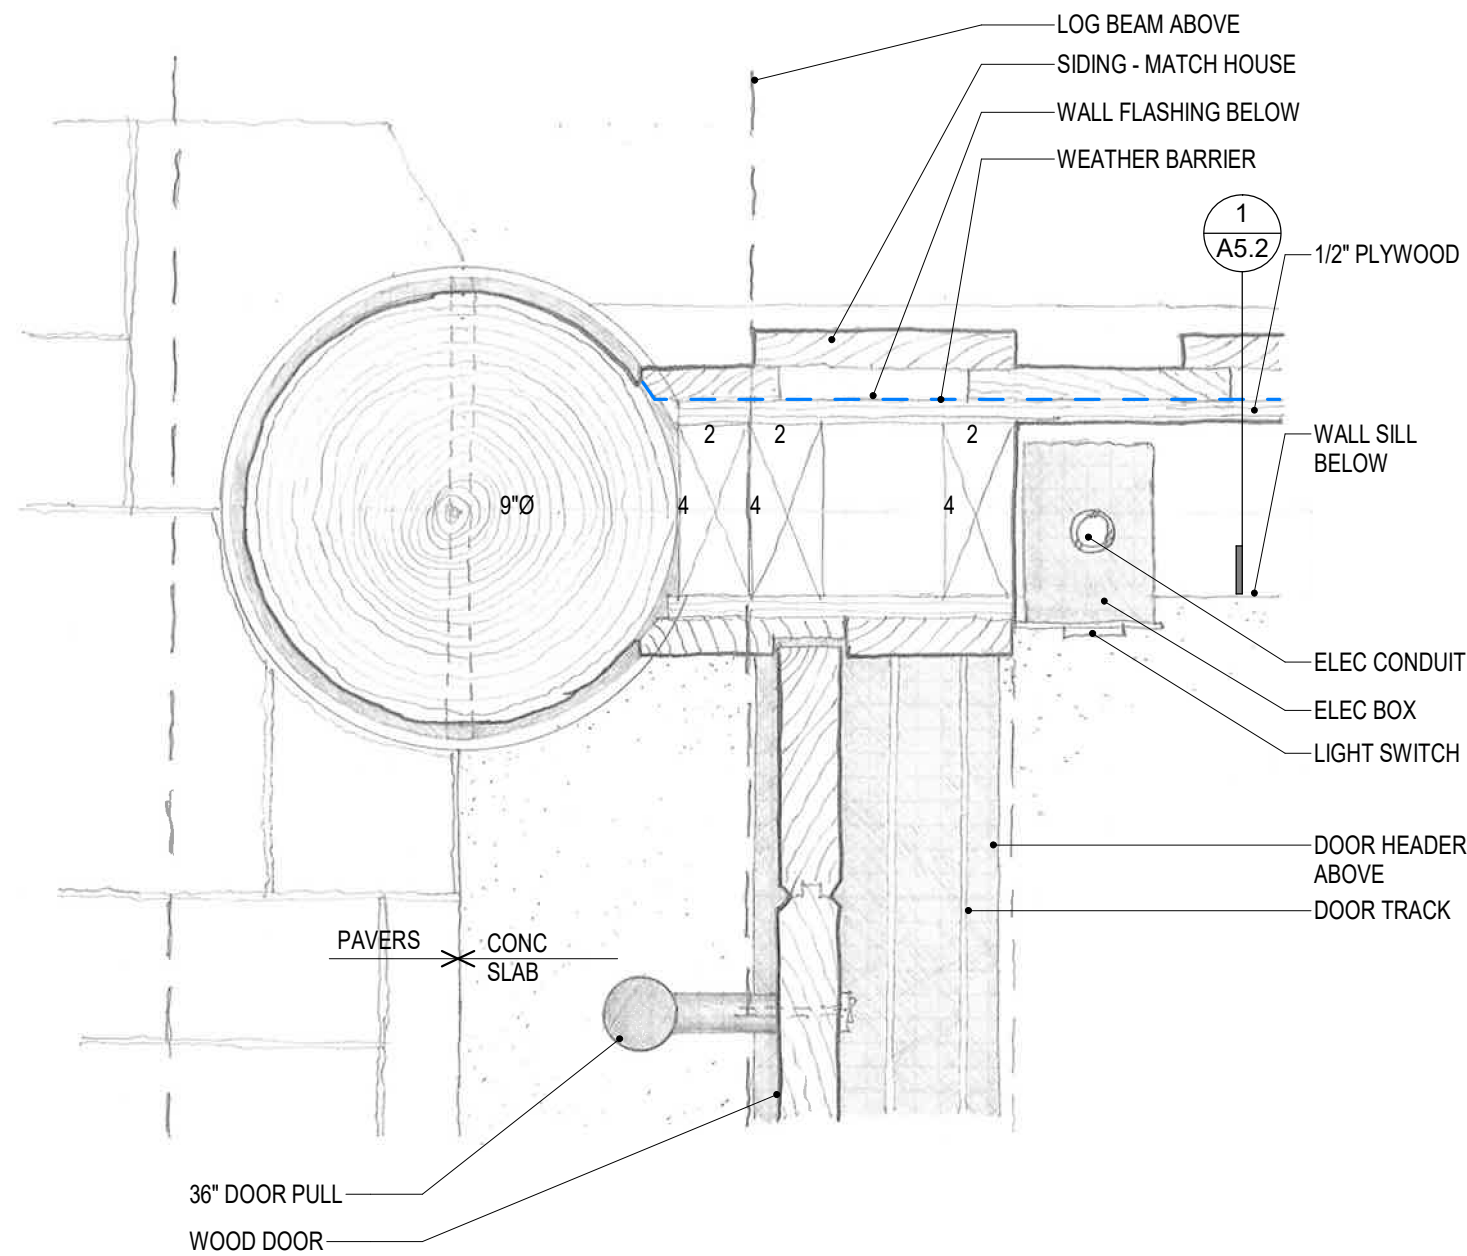


Detail 2.0
SCALE: 12" = 1'-0"

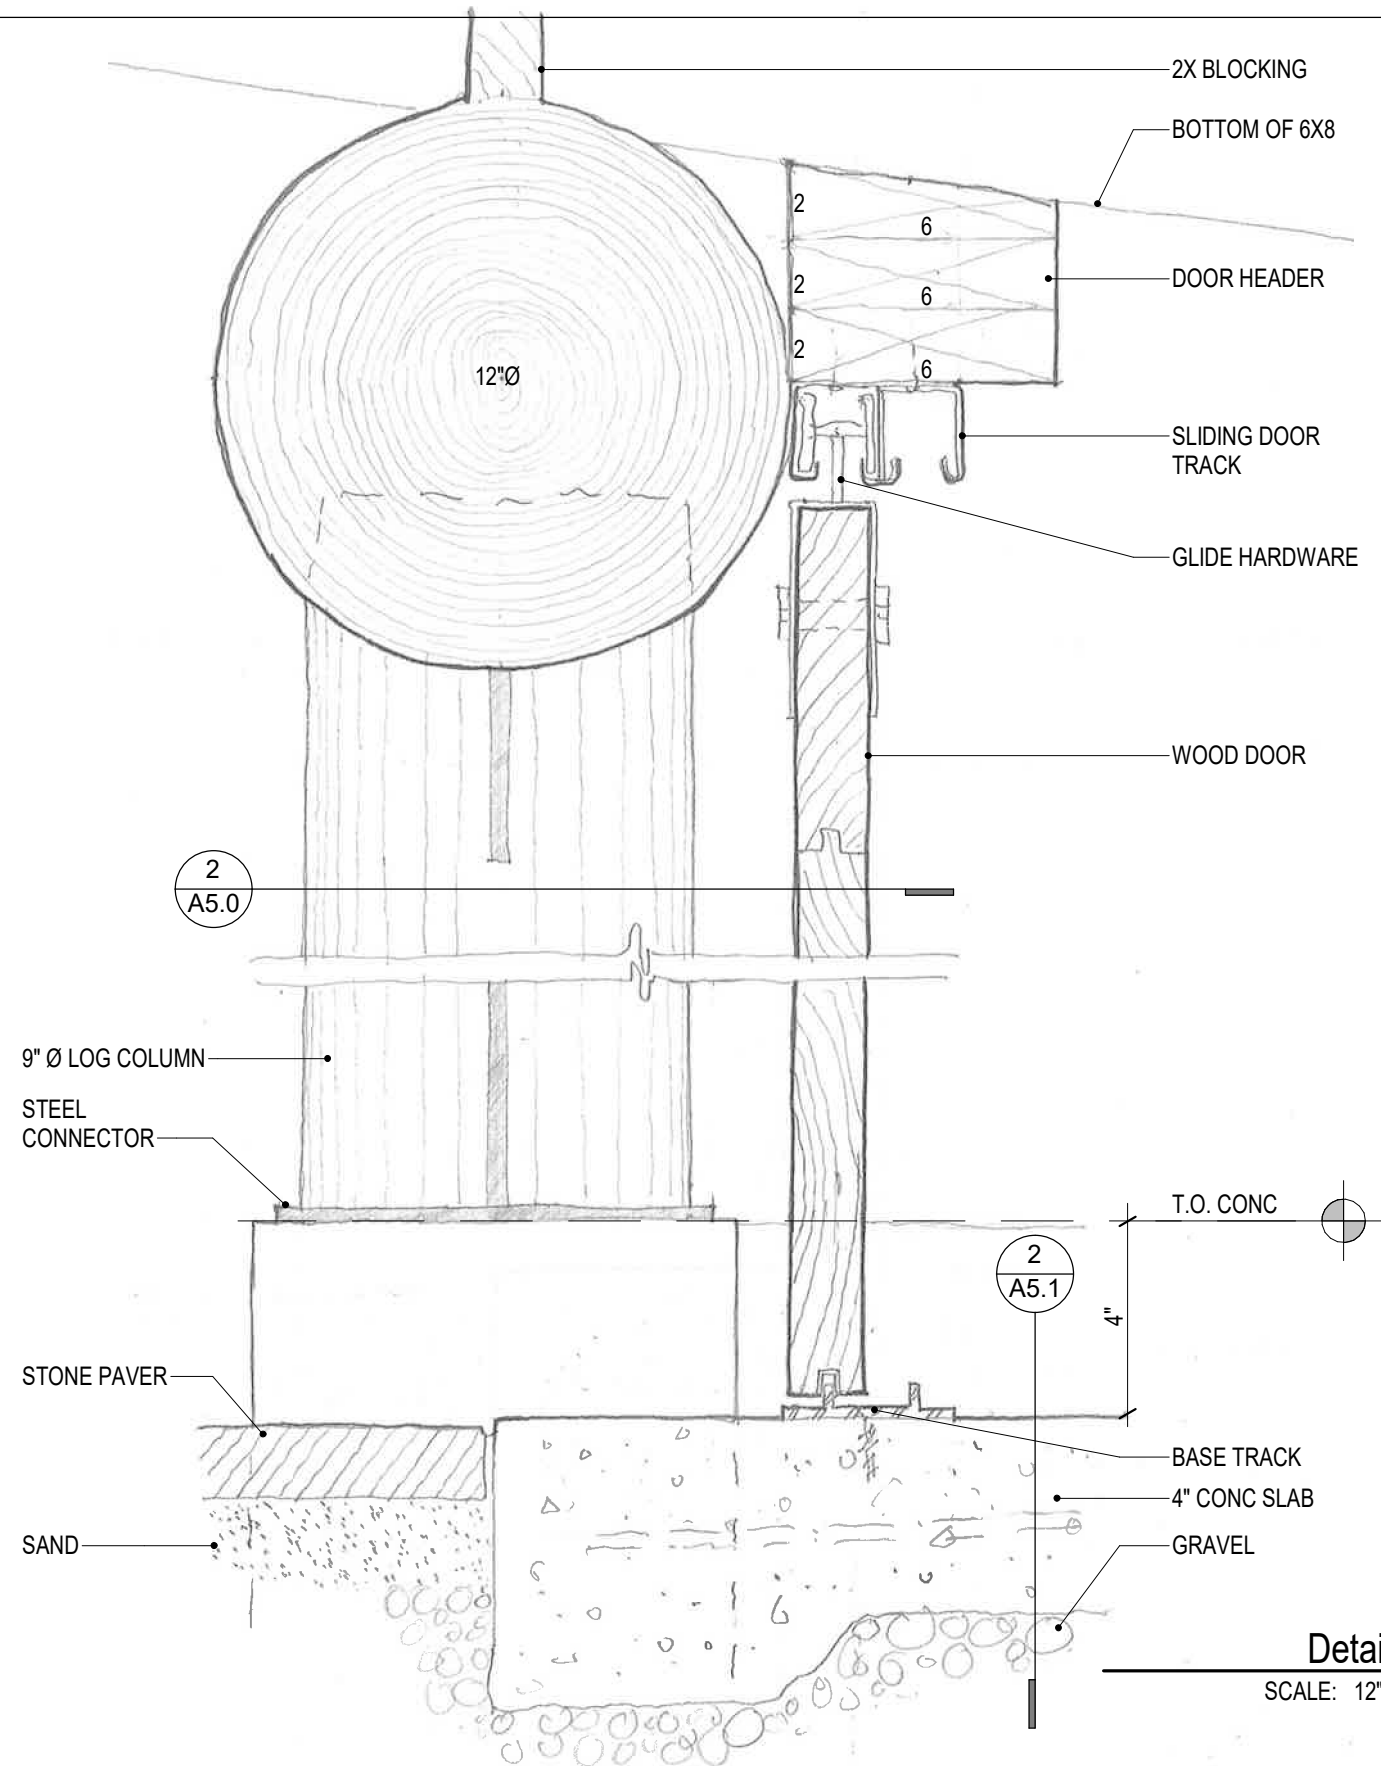

Detail 1.0
SCALE: 12" = 1'-0"


CITY/COUNTY SEAL:	STRUC SEAL:	ARCH SEAL:	studio-skh Sean Haste 1221 E Pike St. Suite 300, Seattle, WA 98122 206.503.3619	Caroline's Carport 12430 S. Lakeshore Rd Chelan, WA 98816	ISSUE DATE: 02/23/22 <table><tr><th>No.</th><th>Description</th><th>Date</th></tr><tr><td>1</td><td>PROGRESS SET</td><td>03/01/23</td></tr><tr><td></td><td></td><td></td></tr><tr><td></td><td></td><td></td></tr></table>	No.	Description	Date	1	PROGRESS SET	03/01/23							Details SCALE: 12" = 1'-0"	A5.0
No.	Description	Date																	
1	PROGRESS SET	03/01/23																	

FOR REVIEW ONLY

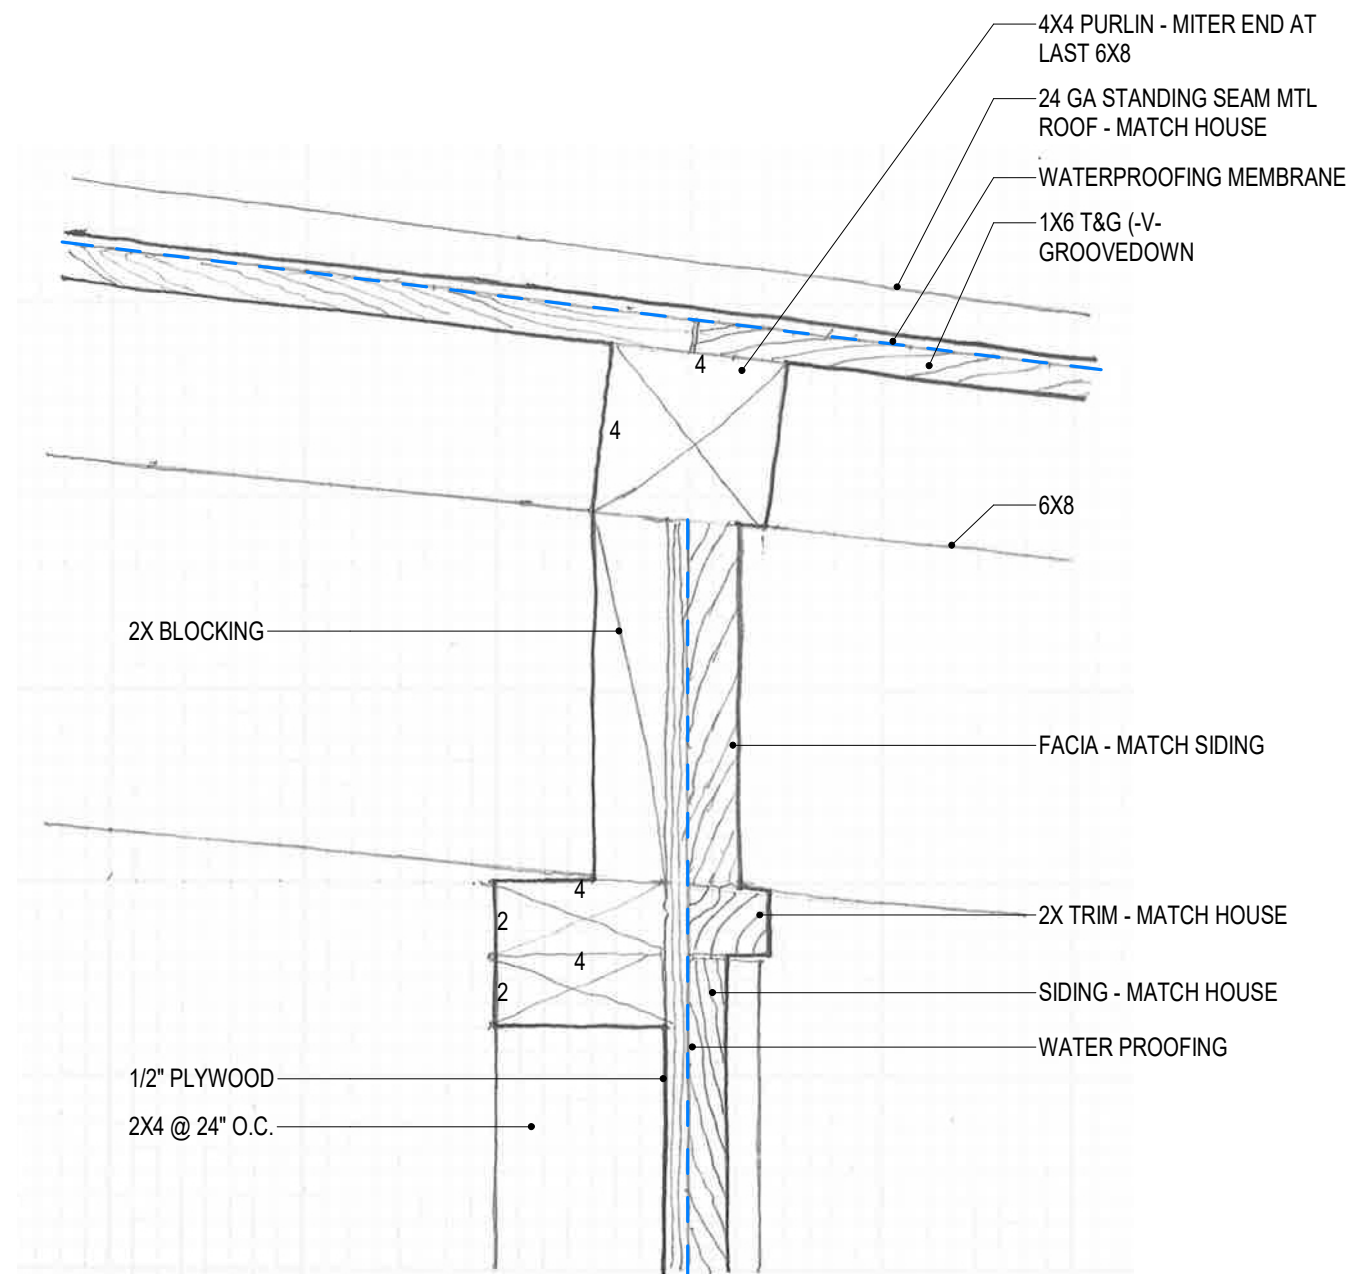

Detail 4.0
SCALE: 12" = 1'-0"

2


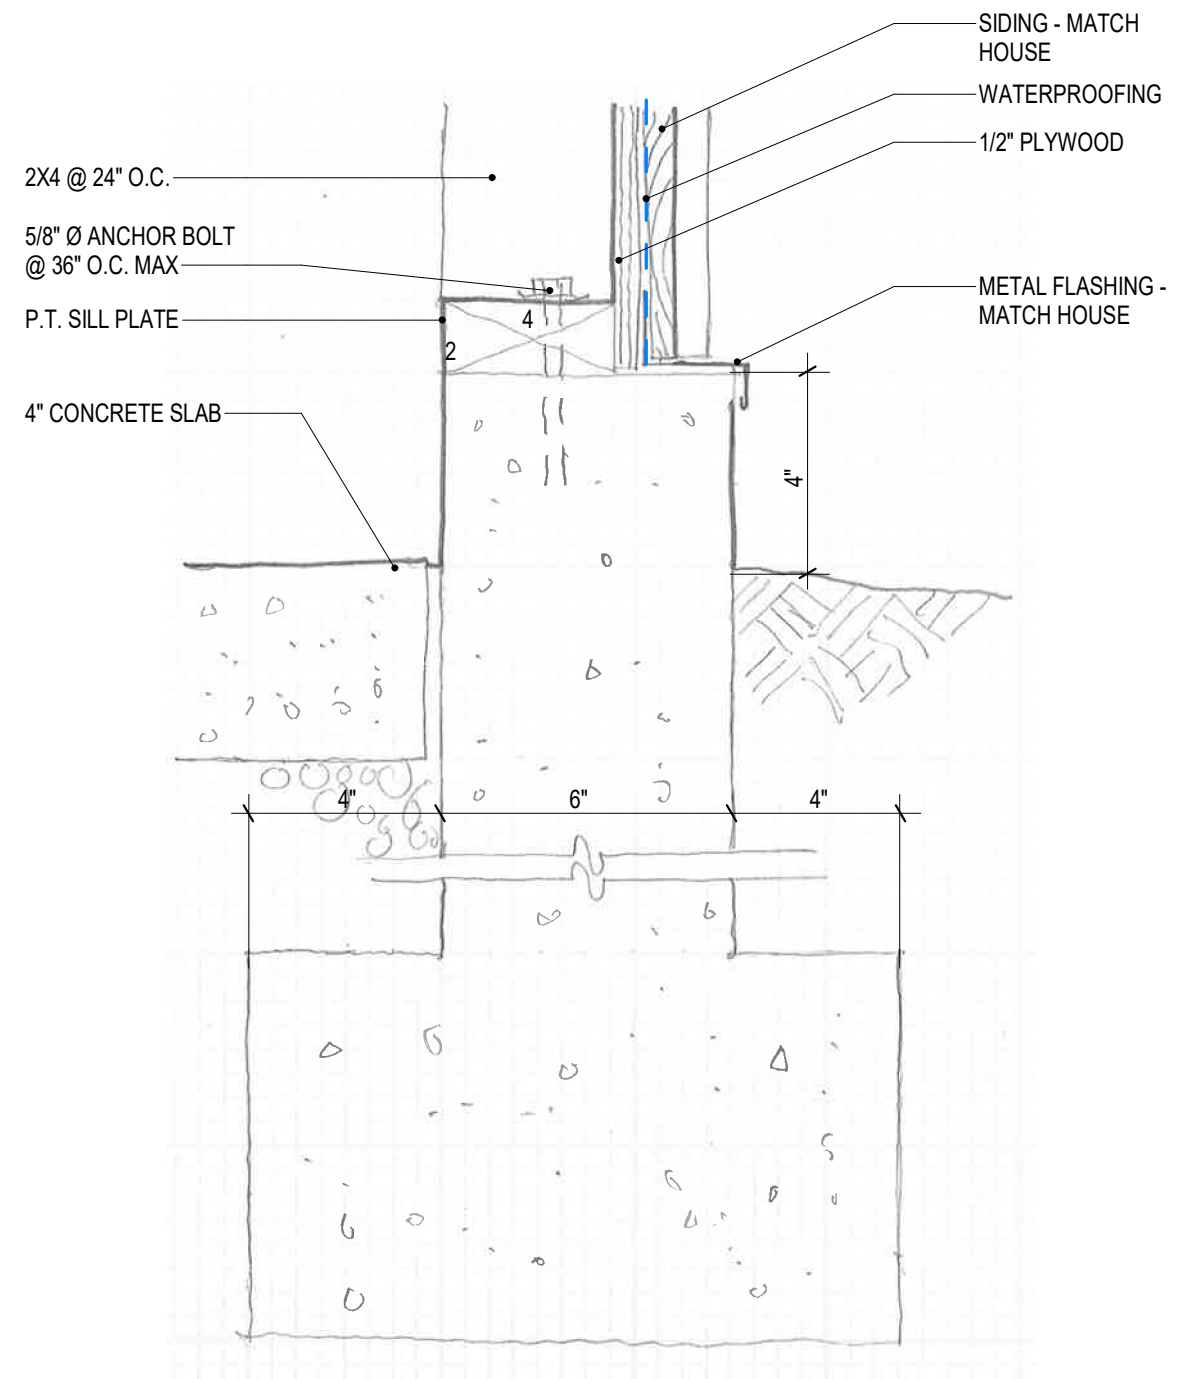


Detail 3.0
SCALE: 12" = 1'-0"

1

CITY/COUNTY SEAL:	STRUC SEAL:	ARCH SEAL:	studio-sk Sean Haste 1221 E Pike St. Suite 300, Seattle, WA 98122 206.503.3619	Caroline's Carport 12430 S. Lakeshore Rd Chelan, WA 98816	ISSUE DATE: 02/23/22 <table><tr><th>No.</th><th>Description</th><th>Date</th></tr><tr><td>1</td><td>PROGRESS SET</td><td>03/01/23</td></tr><tr><td></td><td></td><td></td></tr><tr><td></td><td></td><td></td></tr></table>	No.	Description	Date	1	PROGRESS SET	03/01/23							Details SCALE: 12" = 1'-0"	A5.1
No.	Description	Date																	
1	PROGRESS SET	03/01/23																	

FOR REVIEW ONLY

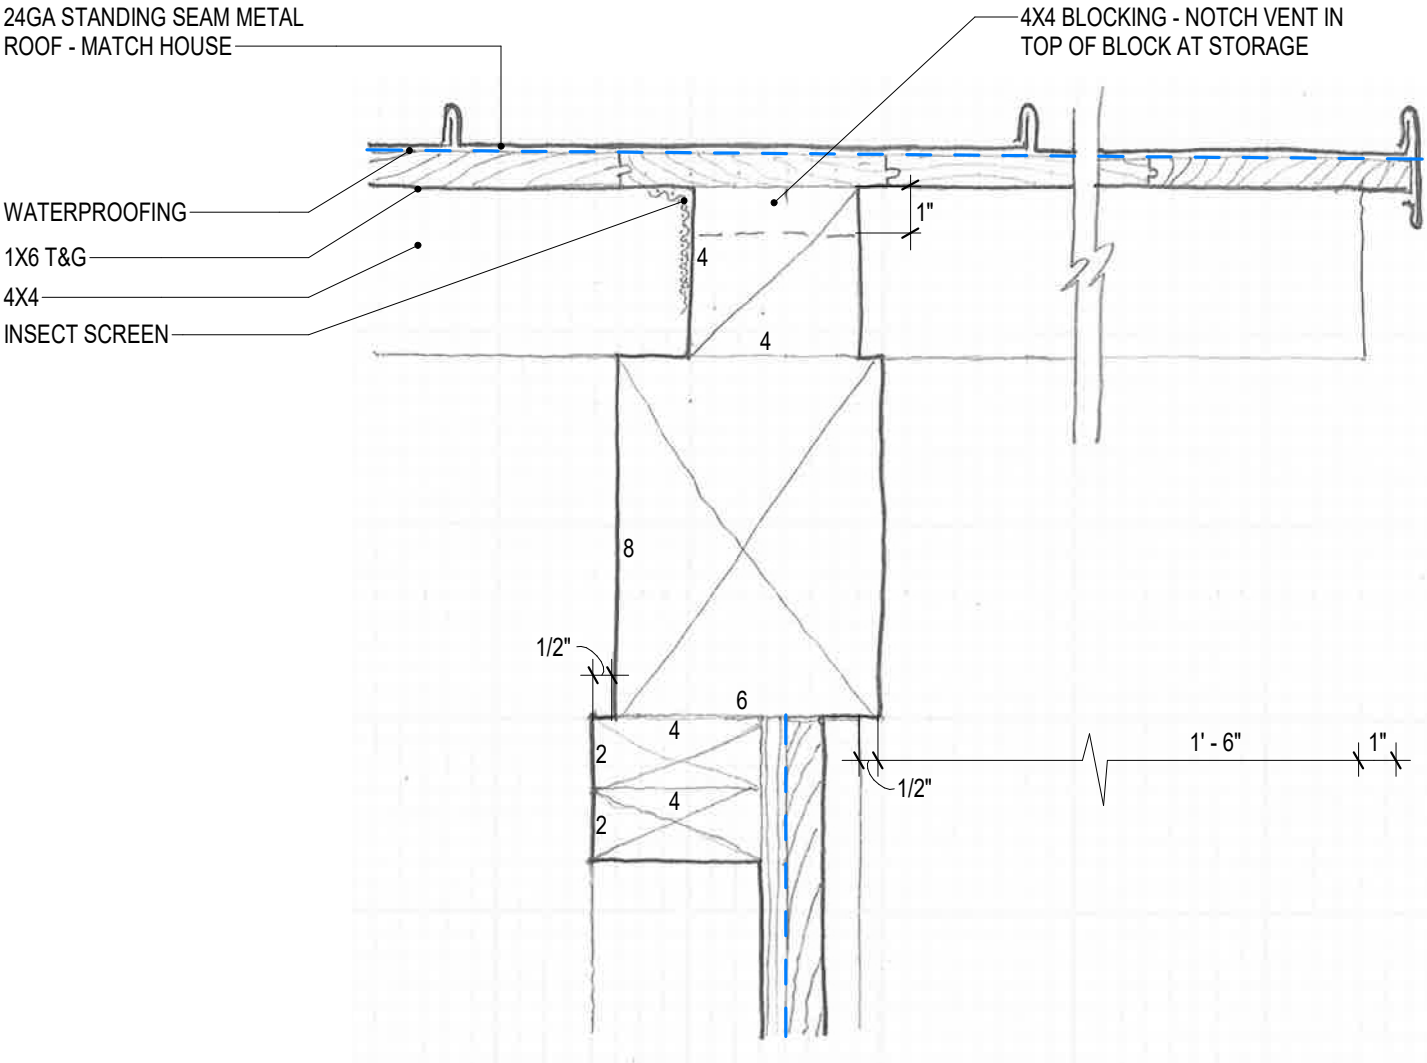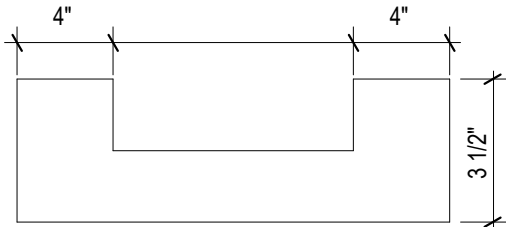

Detail 5.0
SCALE: 12" = 1'-0"

1